



**HIGHWAY FACTORS ATTACHMENT**

**Cottman Avenue Ramp Sign Plan**




**Philadelphia, Pennsylvania**

**HWY23FH014**

(3 pages)

DISTRICT	COUNTY	ROUTE	SECTION	SHEET
6-0	PHILADELPHIA	0095	CP2	25A OF 49
CITY OF PHILADELPHIA				
REVISION NUMBER	REVISIONS			DATE BY

01/17/2014 PLOTTED: D-9012 CADD (02-90) REVISED (10-04) SEE SHEET 24 OPERATOR: FILE NAME: X:\8265\8265\_02\CAD\1\1\CP2\SignLighting\CP2s1gn07.dgn (Default)

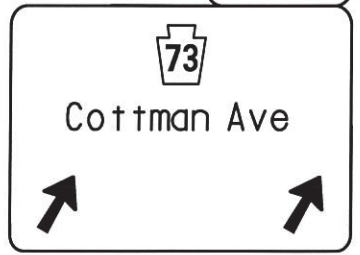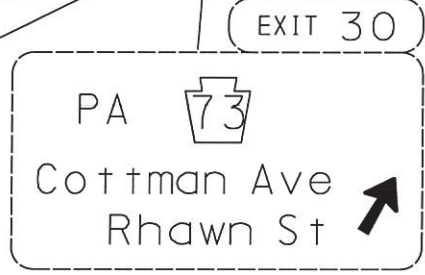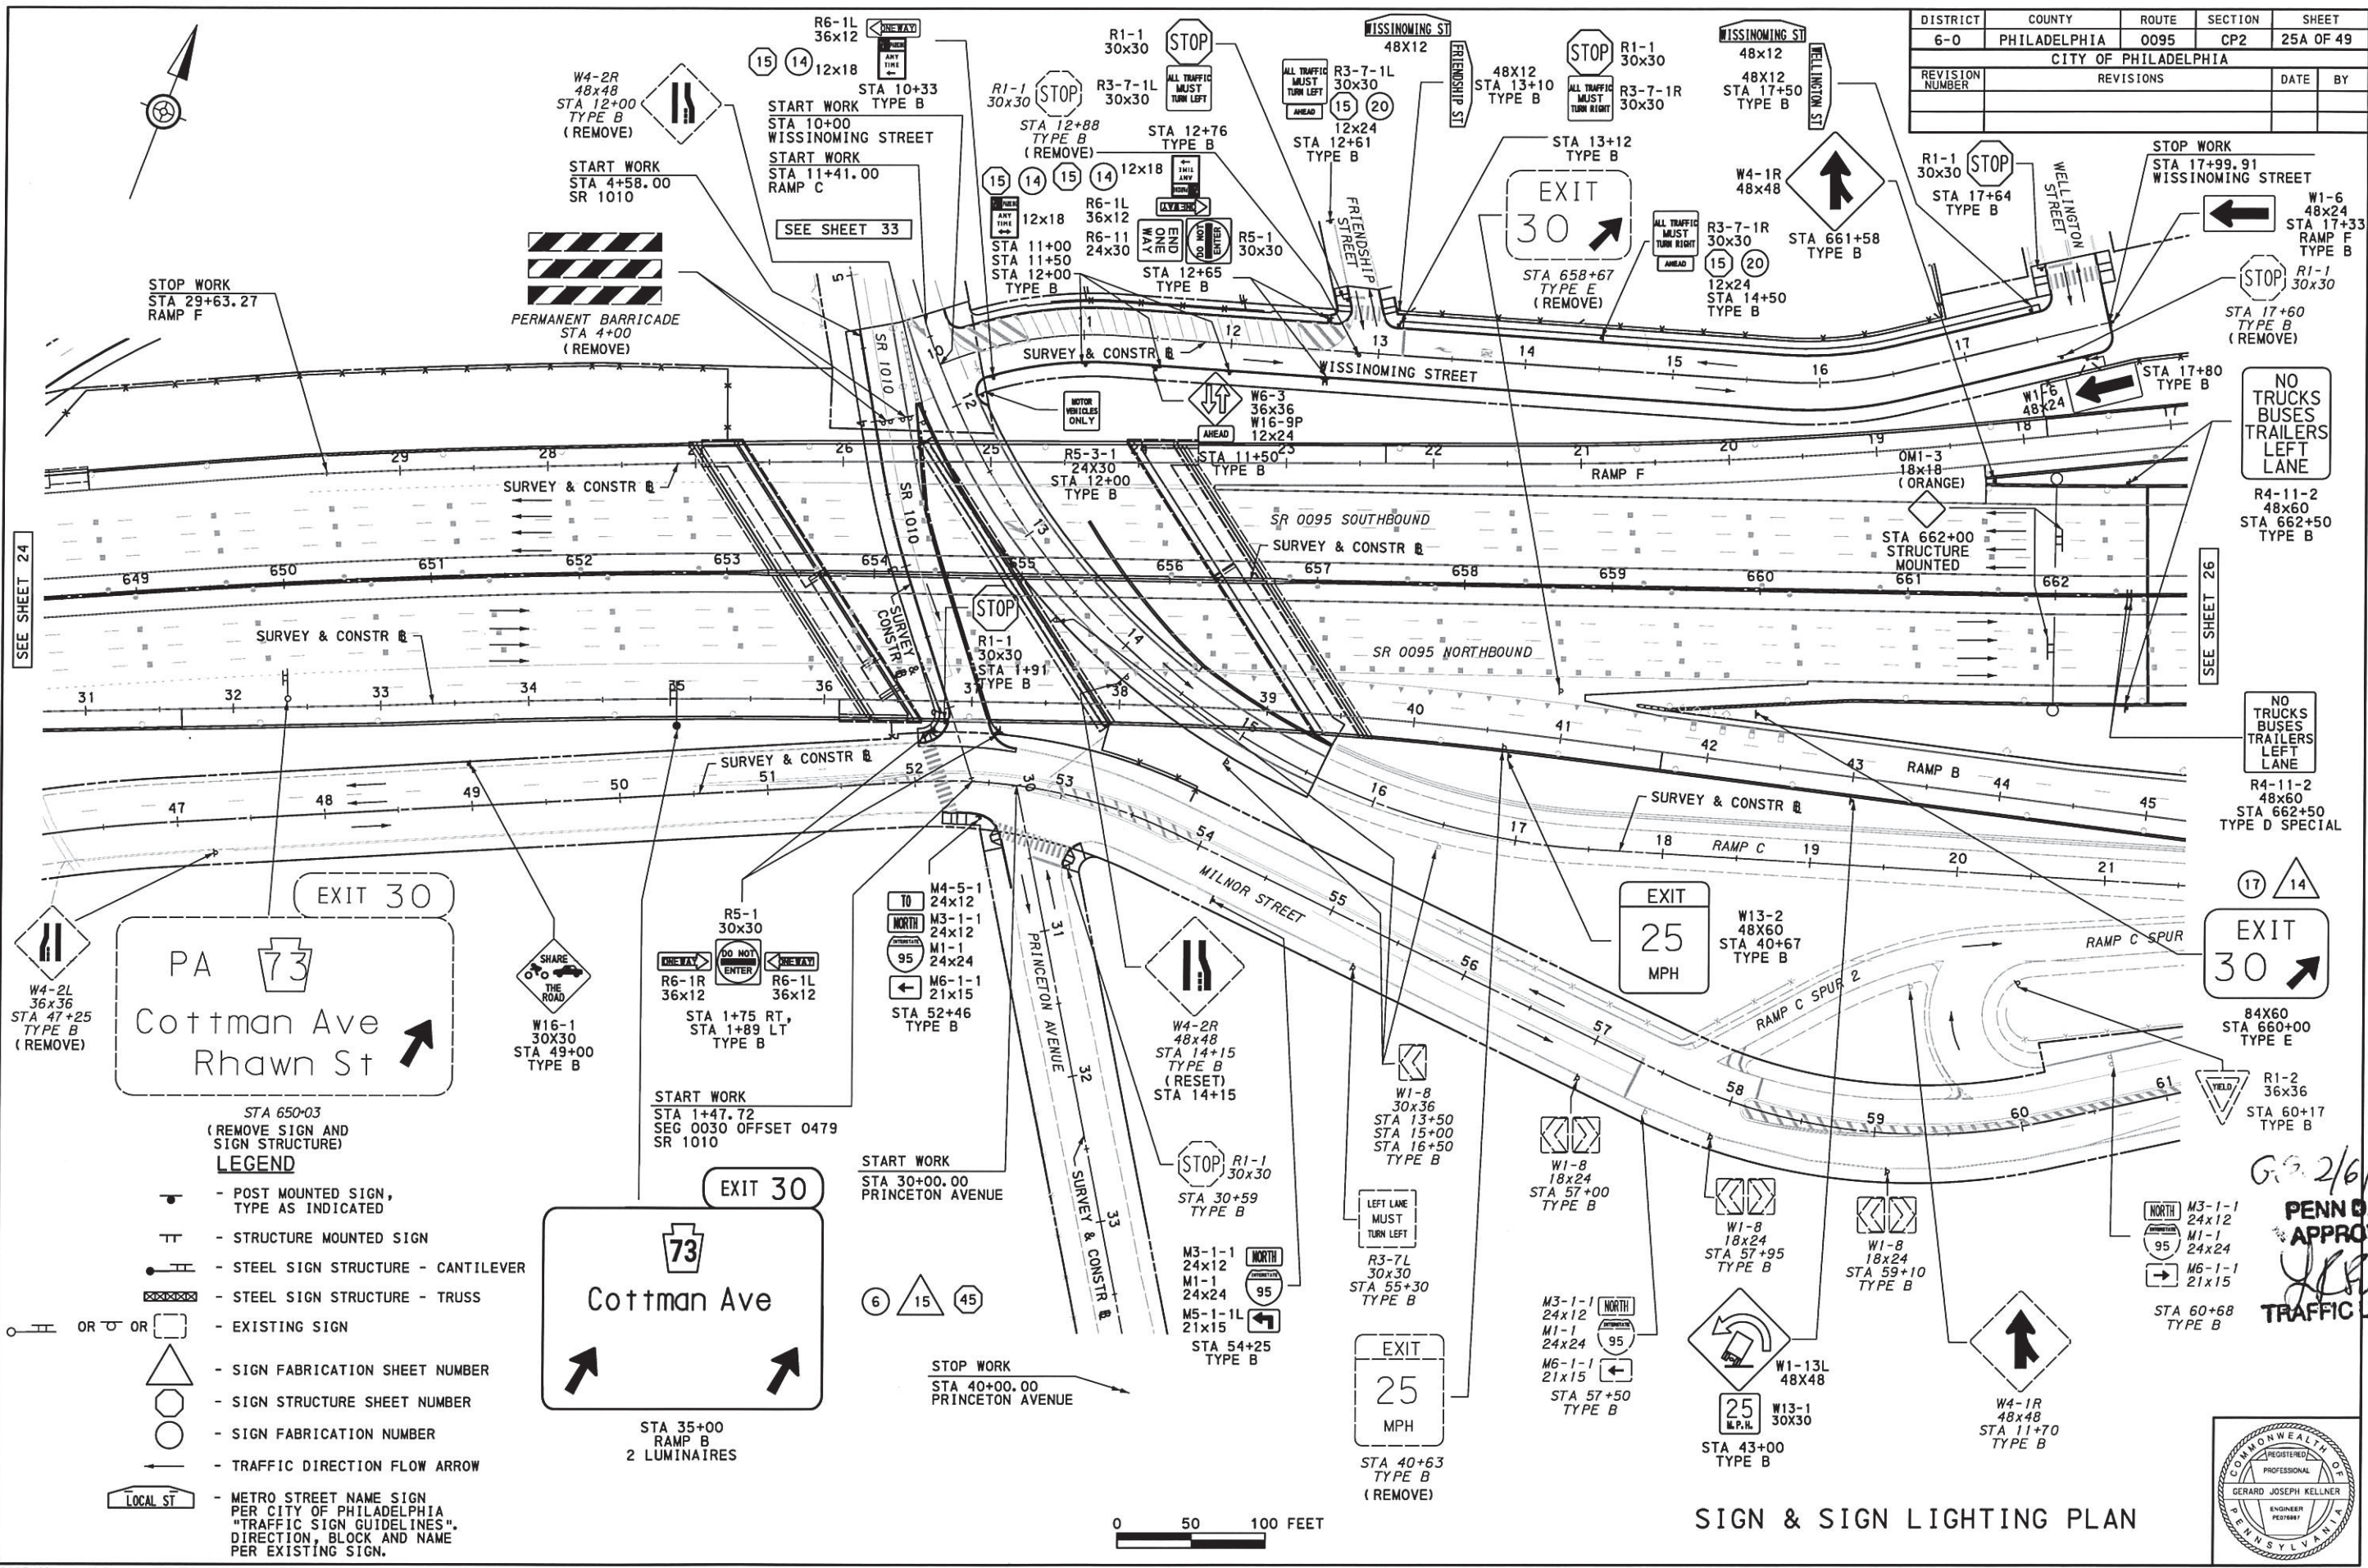

- STA 650+03  
(REMOVE SIGN AND SIGN STRUCTURE)
- LEGEND**
- POST MOUNTED SIGN, TYPE AS INDICATED
  - STRUCTURE MOUNTED SIGN
  - STEEL SIGN STRUCTURE - CANTILEVER
  - STEEL SIGN STRUCTURE - TRUSS
  - EXISTING SIGN
  - SIGN FABRICATION SHEET NUMBER
  - SIGN STRUCTURE SHEET NUMBER
  - SIGN FABRICATION NUMBER
  - TRAFFIC DIRECTION FLOW ARROW
  - METRO STREET NAME SIGN PER CITY OF PHILADELPHIA "TRAFFIC SIGN GUIDELINES", DIRECTION, BLOCK AND NAME PER EXISTING SIGN.




**SIGN & SIGN LIGHTING PLAN**



G.S. 2/6/14  
**PENN. O.T. APPROVED**  
*[Signature]*  
**TRAFFIC UNIT 6-0**

DISTRICT	COUNTY	ROUTE	SECTION	SHEET
6-0	PHILADELPHIA	0095	CP2	26 OF 49
CITY OF PHILADELPHIA				
REVISION NUMBER	REVISIONS	DATE	BY	

06/28/2011 PLOTTED: D-9012 CADD (02-90) REVISED (10-04) OPERATOR: X:\8200s\8265\_02\CIVIL\CP2\SIGN\ING\CP2SIGN08.dgn (Default)

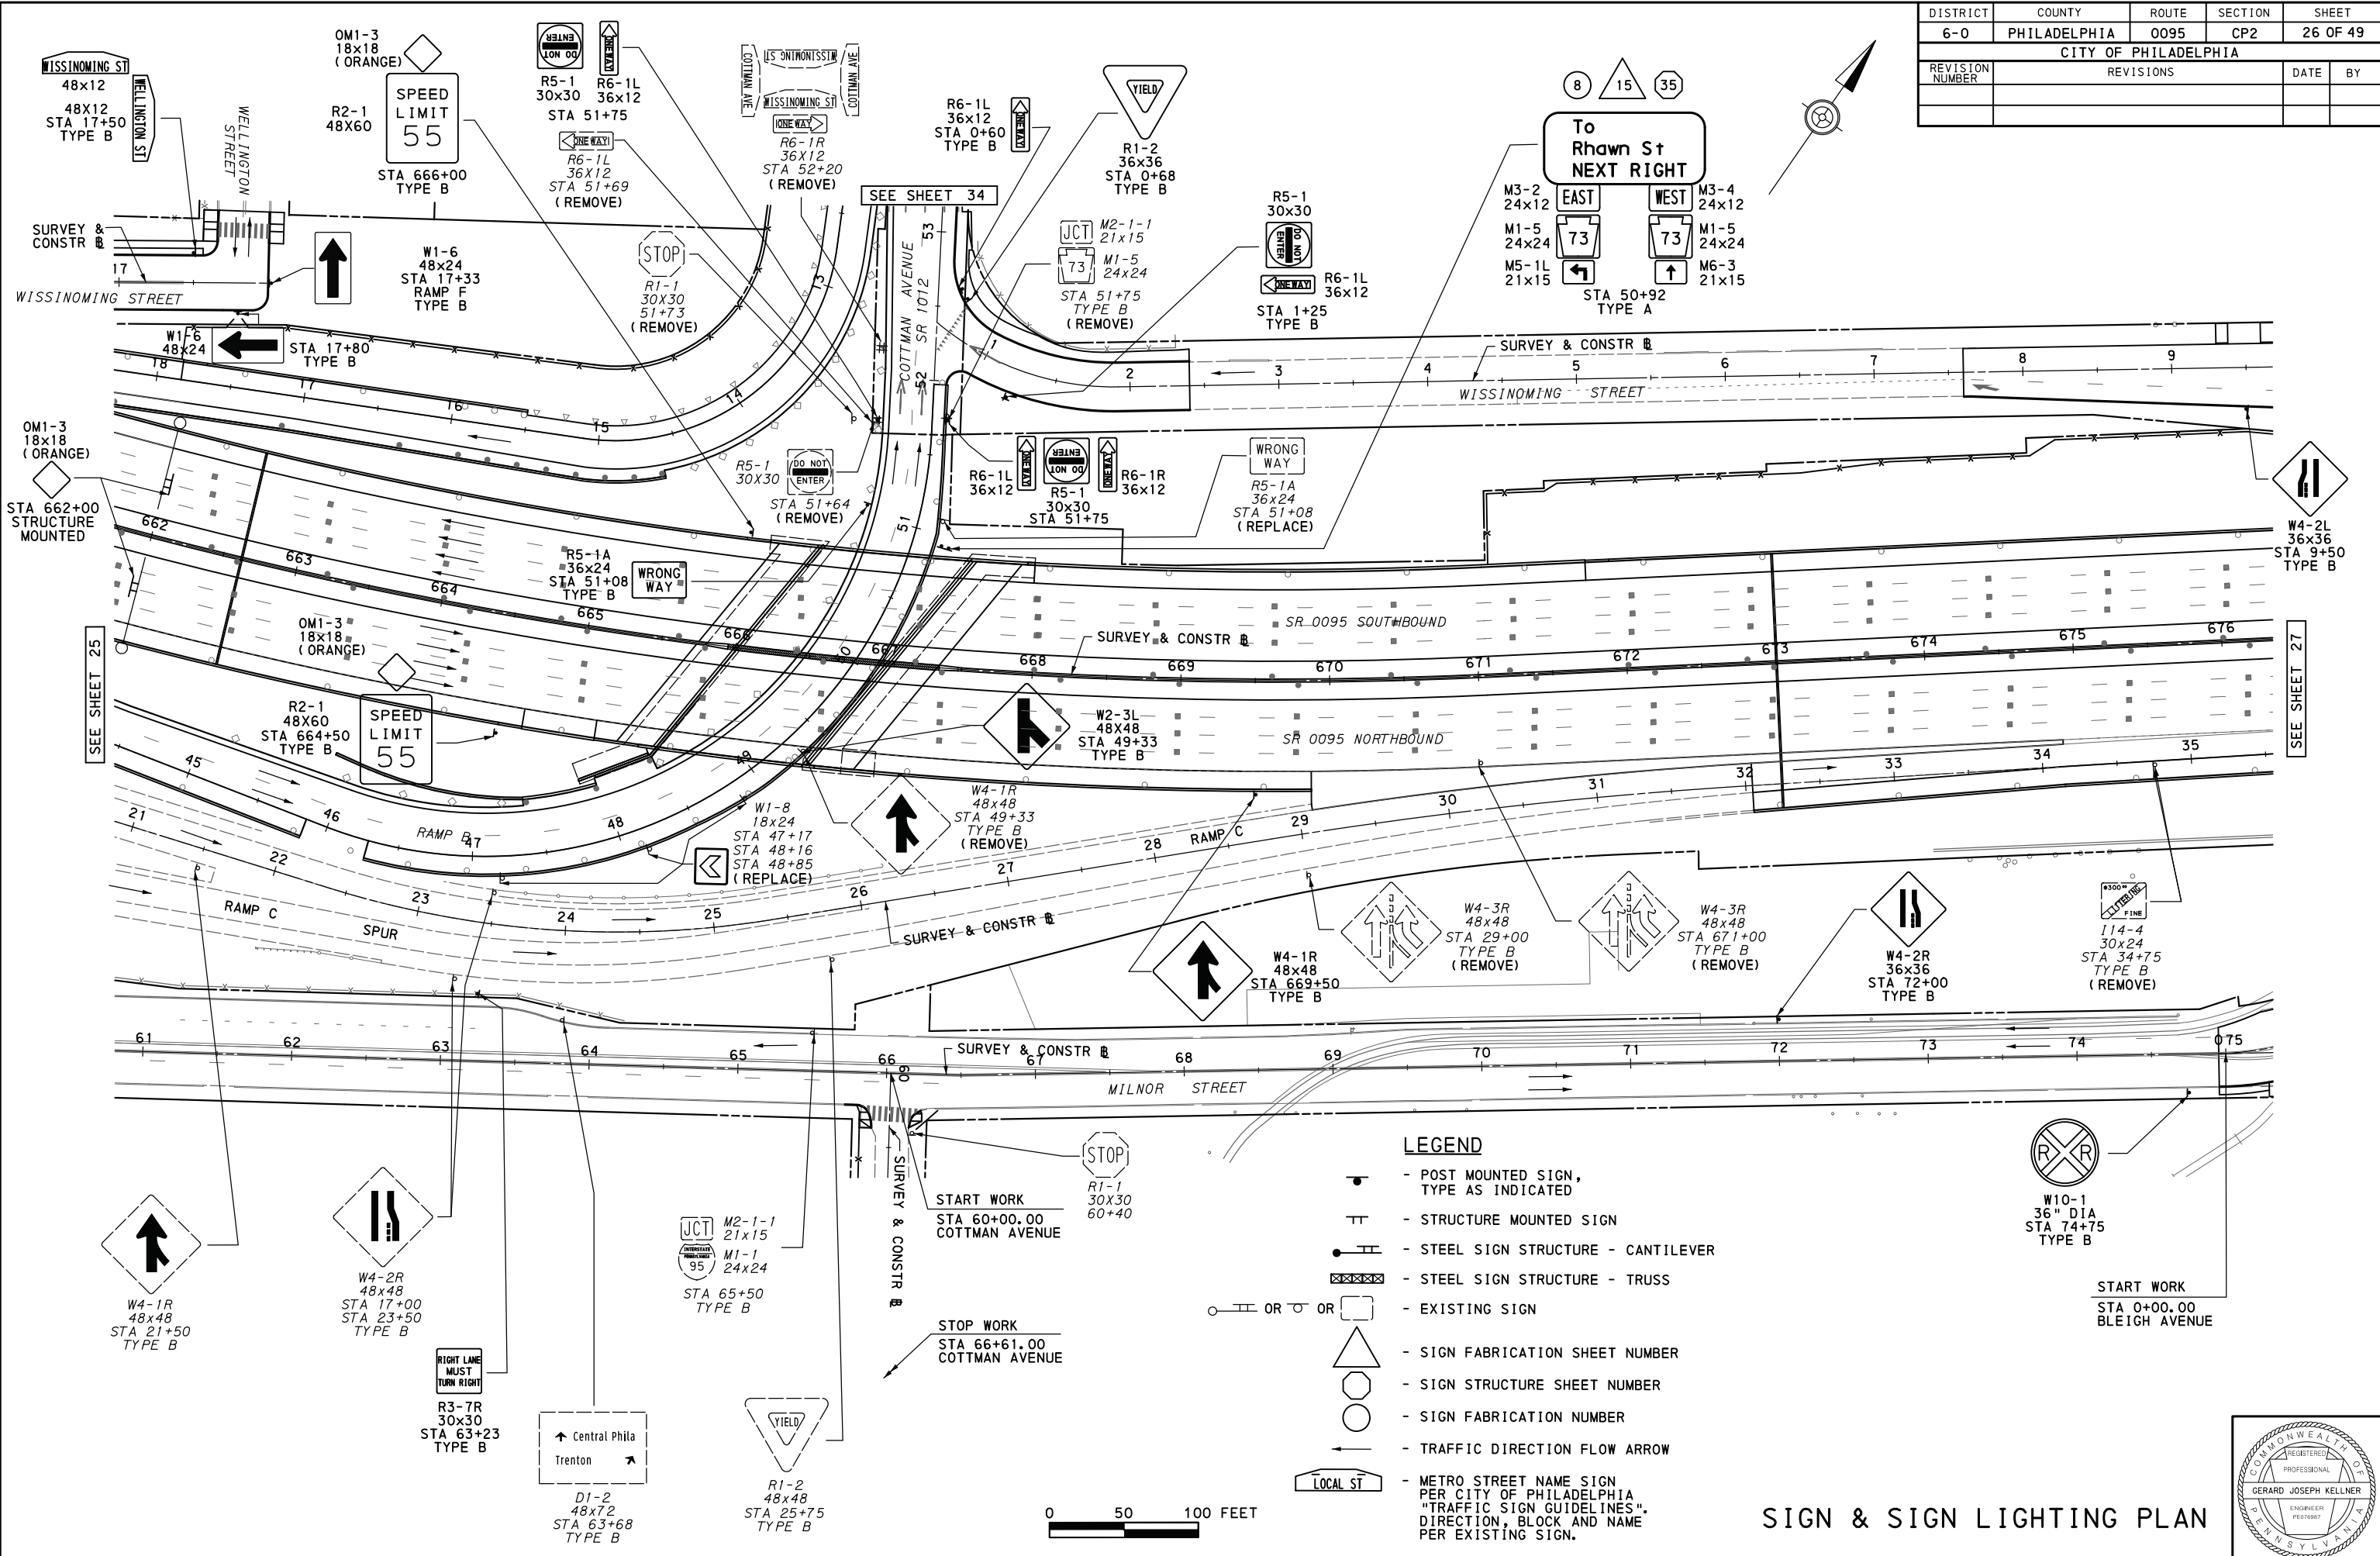

**LEGEND**

- POST MOUNTED SIGN, TYPE AS INDICATED
- STRUCTURE MOUNTED SIGN
- STEEL SIGN STRUCTURE - CANTILEVER
- STEEL SIGN STRUCTURE - TRUSS
- EXISTING SIGN
- SIGN FABRICATION SHEET NUMBER
- SIGN STRUCTURE SHEET NUMBER
- SIGN FABRICATION NUMBER
- TRAFFIC DIRECTION FLOW ARROW
- METRO STREET NAME SIGN PER CITY OF PHILADELPHIA "TRAFFIC SIGN GUIDELINES", DIRECTION, BLOCK AND NAME PER EXISTING SIGN.



**SIGN & SIGN LIGHTING PLAN**

